


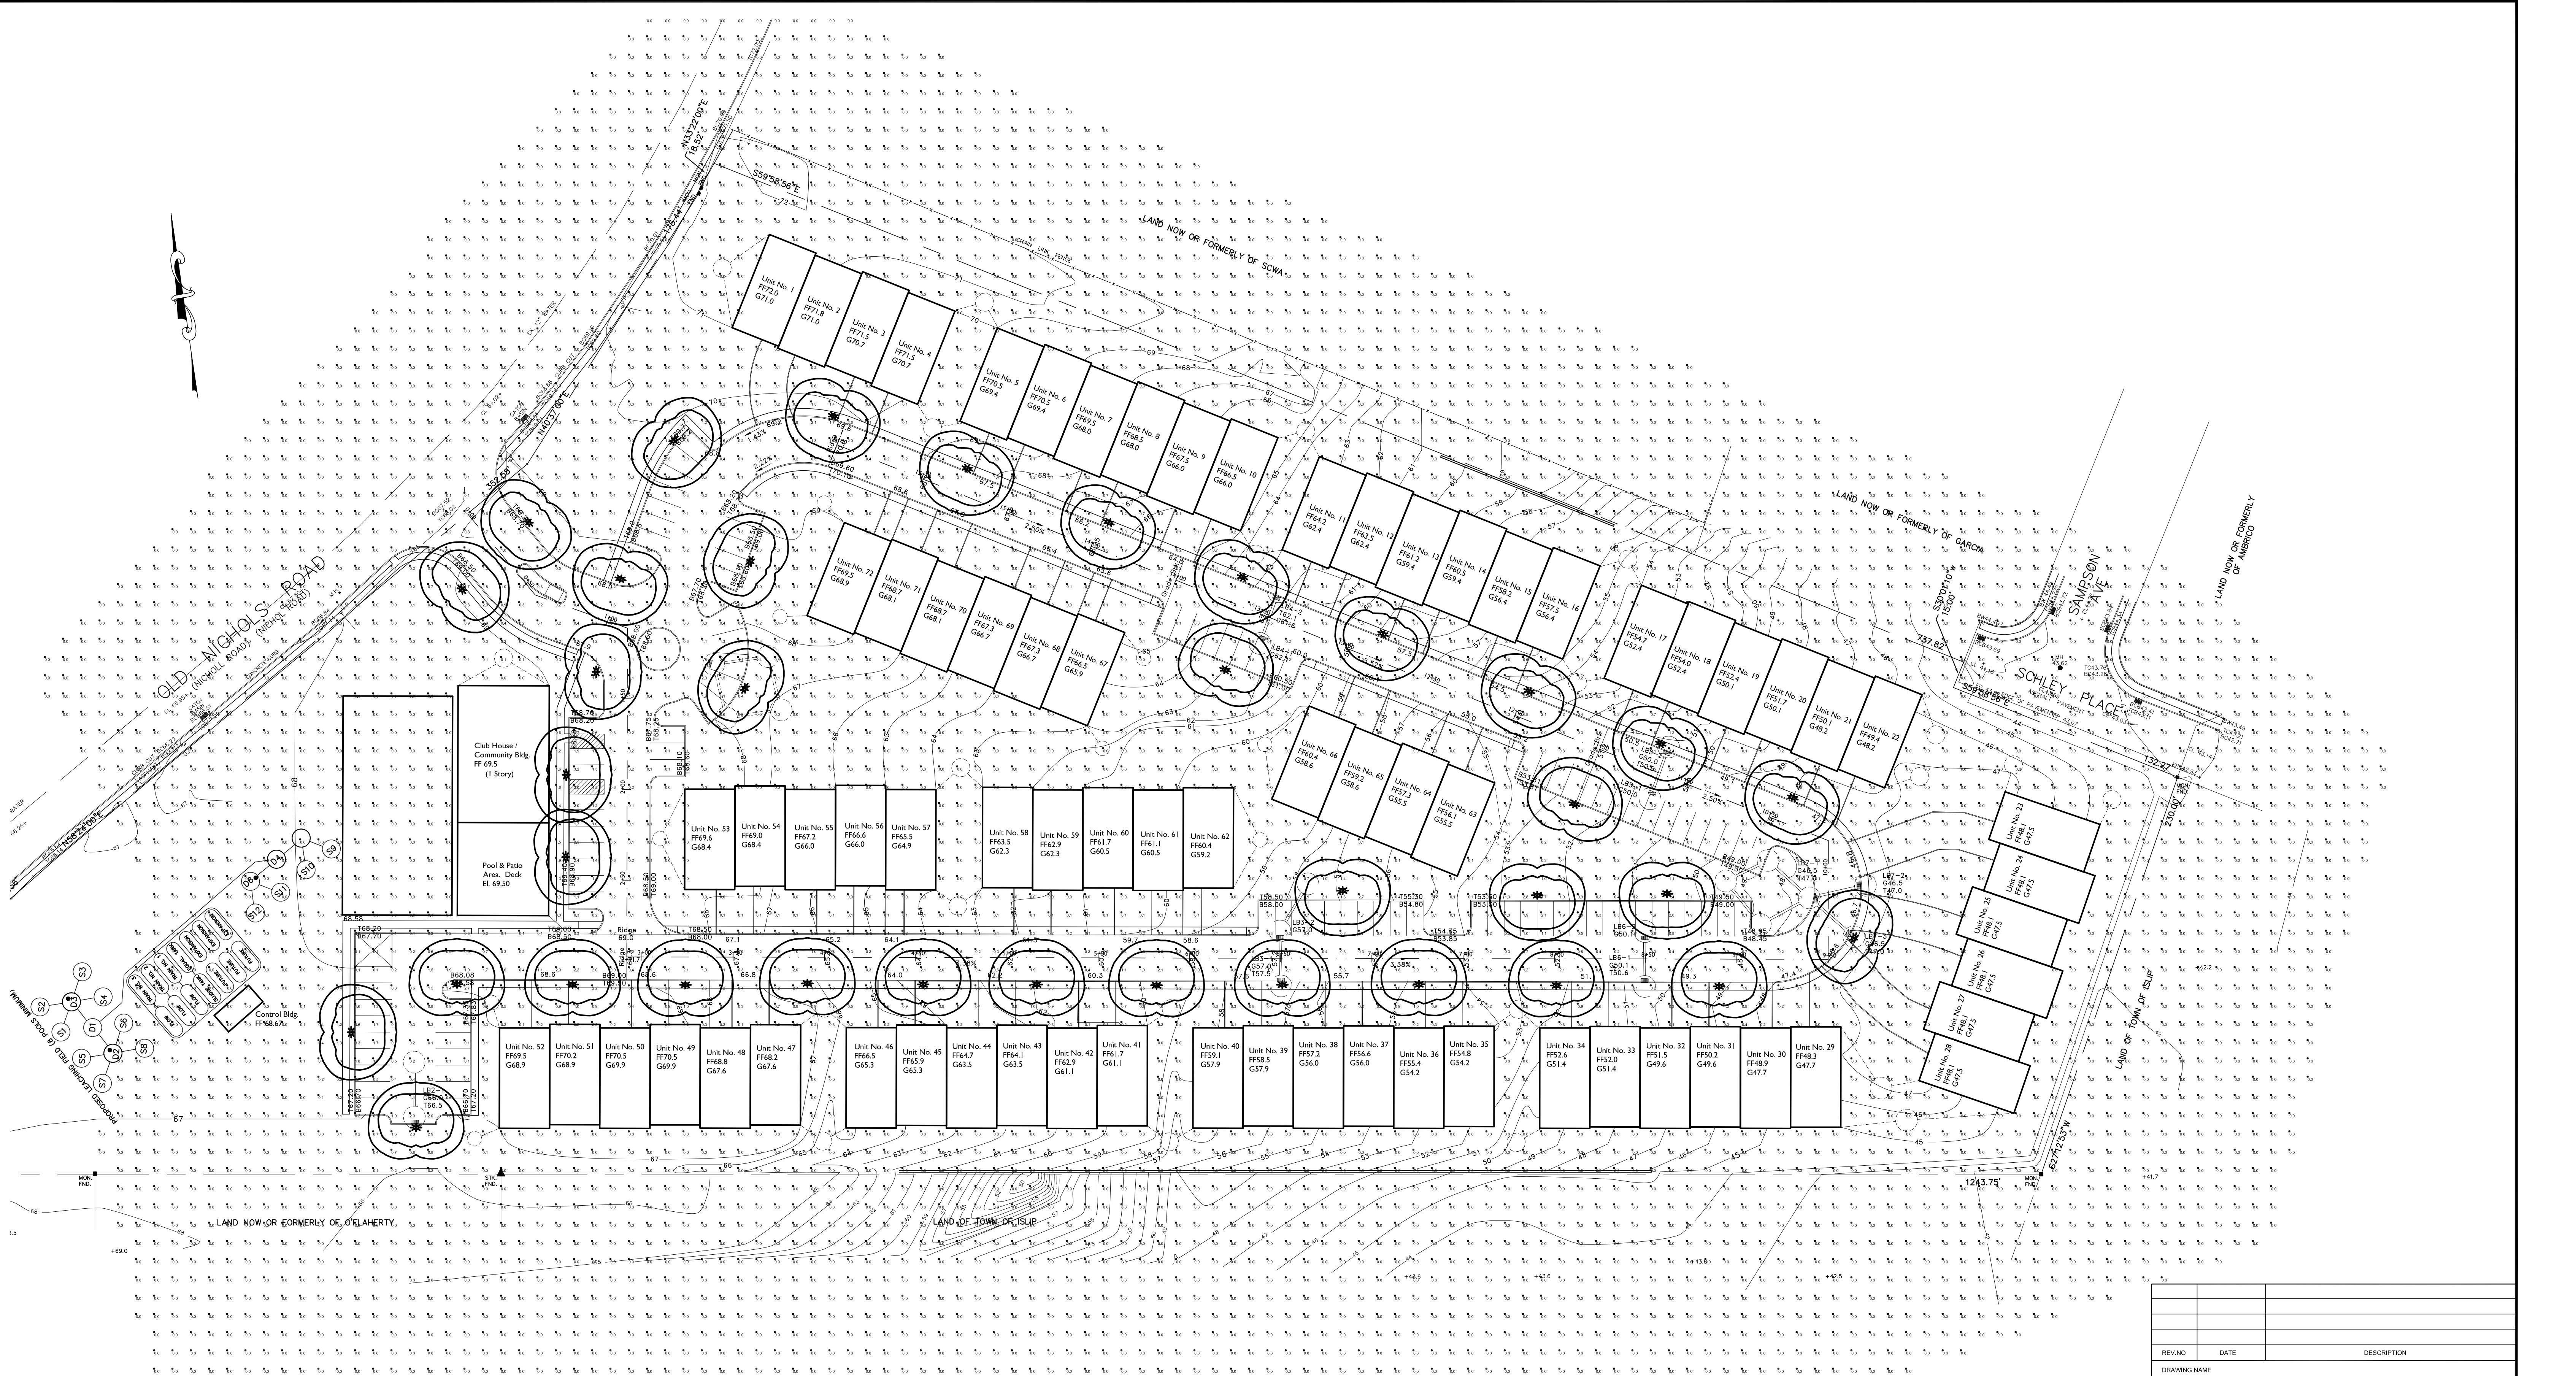

Luminaire Schedule						
Project: All Projects						
Symbol	Qty	Label	Arrangement	Lumens	LLF	Description
	36	Riverside Park Luminaire MagniFlood Fixture	SINGLE	6300	0.800	12' Mounting Height Post Top Luminaire 70 watt HPS -type 3 distribution

Numeric Summary					
Project: All Projects					
Label	CalcType	Units	Avg	Avg/Min	
CalcPts	Illuminance	Fc	0.18	0.00	

SCTM : 504-17-03-07&08

Lighting Plan			
PROJECT The Preserve at Islandia Site Plan			
APPLICANT Islandia Partners LLC 399 West John Street Hicksville, New York 11801			
PREPARED BY R&W / Engineers, P.C. 132 East Main Street, Bay Shore, New York 11706 Ph (631) 969-8535 Fax (631) 969-8518			
DRAWN BY MLW	DESIGNED BY MLW	PROJECT NO. ip101	SP8.1
CHECKED BY MLW	DATE LAR	NOV. 2007	